

McGill Smith Punshon, Inc.  
3700 Park 42 Drive Suite 190B  
Cincinnati, Ohio 45241-2097  
Tel: 513-759-0004 • Fax: 513-563-7099  
Engineers • Architects • Surveyors  
Planners • Landscape Architects



Lee Grosser Associates Inc.  
Consulting Engineers  
2000 Alexandria Pike  
Highland Hts. Ky 41076  
859-441-0174 fax  
859-441-0172 fax

Issue/Revision	Revision Number	Date
BD/PERMIT ISSUE	09/13/06	

Sheet Title	Project No.	Scale	Sheet No.	Drawn By	Project Mgr.
FIRST FLOOR ELECTRICAL PLANS	3338	AS NOTED	E20	FBS	LCC

MUHLHAUSER BARN  
AT  
BECKETT PARK  
8558 BECKETT ROAD  
WEST CHESTER, OHIO 45069

Project No. 3338  
Scale AS NOTED  
Sheet No. E20  
Drawn By FBS  
Project Mgr. LCC


### LUMINAIRE SCHEDULE

CALLOUT	SYMBOL	DESCRIPTION	MODEL	INPUT WATTS	VOLTS
A		CEILING FAN 2501 WITH 25673 BLADE PROVIDE DOWNRODS AS REQUIRED		300	120V 1P 2W
B		4' SURFACE STRIP COLUMBIA LIGHTING CS4-232-EB8 120		90	120V 1P 2W
C		4' SURFACE STRIP COLUMBIA LIGHTING VL4-232-EB120W-VLT5		90	120V 1P 2W
D		PENDANT MCFADDEN TREND A20 BLACK LARGE IAR GLASS FROSTED WITH CAST DOME GUARD		150	120V 1P 2W
E		DUAL HEAD UPLIGHT MCFADDEN C429-2 BLACK		150	120V 1P 2W
EM		EMERGENCY WALL PACK DUALITE L22		10	120V 1P 2W
F		WALL SCONCE MCFADDEN 4809B BLACK		150	120V 1P 2W
G		CANOPY FIXTURE MCFADDEN A19 BLACK		150	120V 1P 2W
H		WALL MTD. EXTERIOR MCFADDEN A19 BLACK ARM WALL BRACKET B1		150	120V 1P 2W
J		POST MTD. EXTERIOR MCFADDEN A19 BLACK ARM POST BRACKET B8		150	120V 1P 2W
X		EXIT DUALITE LTRW		10	120V 1P 2W
X1		REMOTE HEAD DUALITE OMSSM0605		5	120V 1P 2W

NOTE: ALL FIXTURES, ACCESSORIES, BOXES, CONDUITS, ETC. SHALL BE BLACK.


### FIRST FLOOR ELECTRICAL POWER PLAN

SCALE: 1/8" = 1'-0"

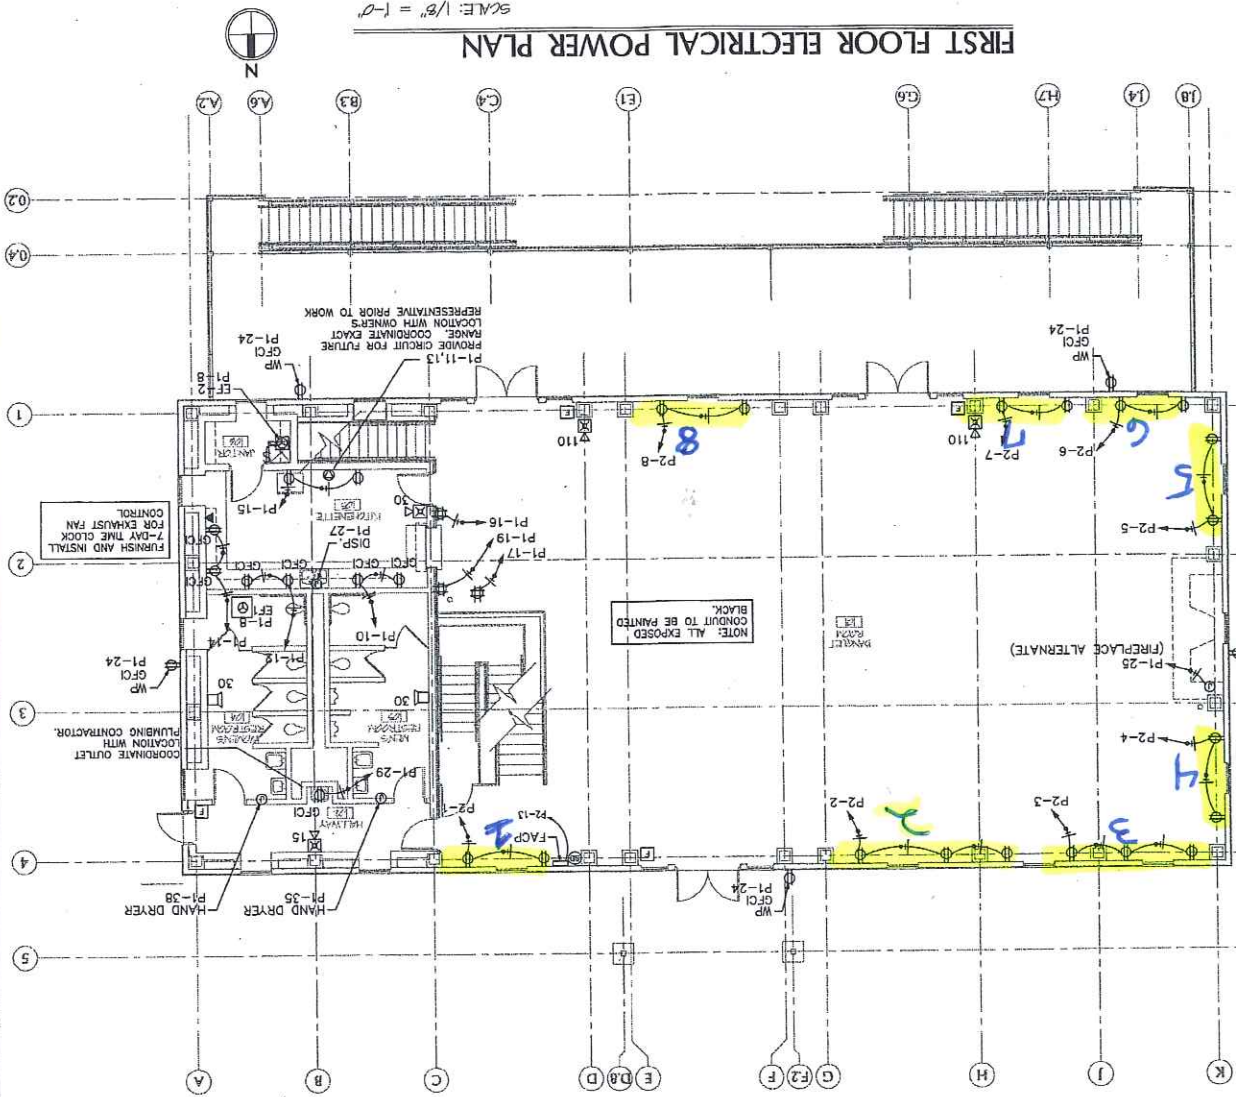

SCALE: 1/8" = 1'-0"

# FIRST FLOOR ELECTRICAL POWER PLAN

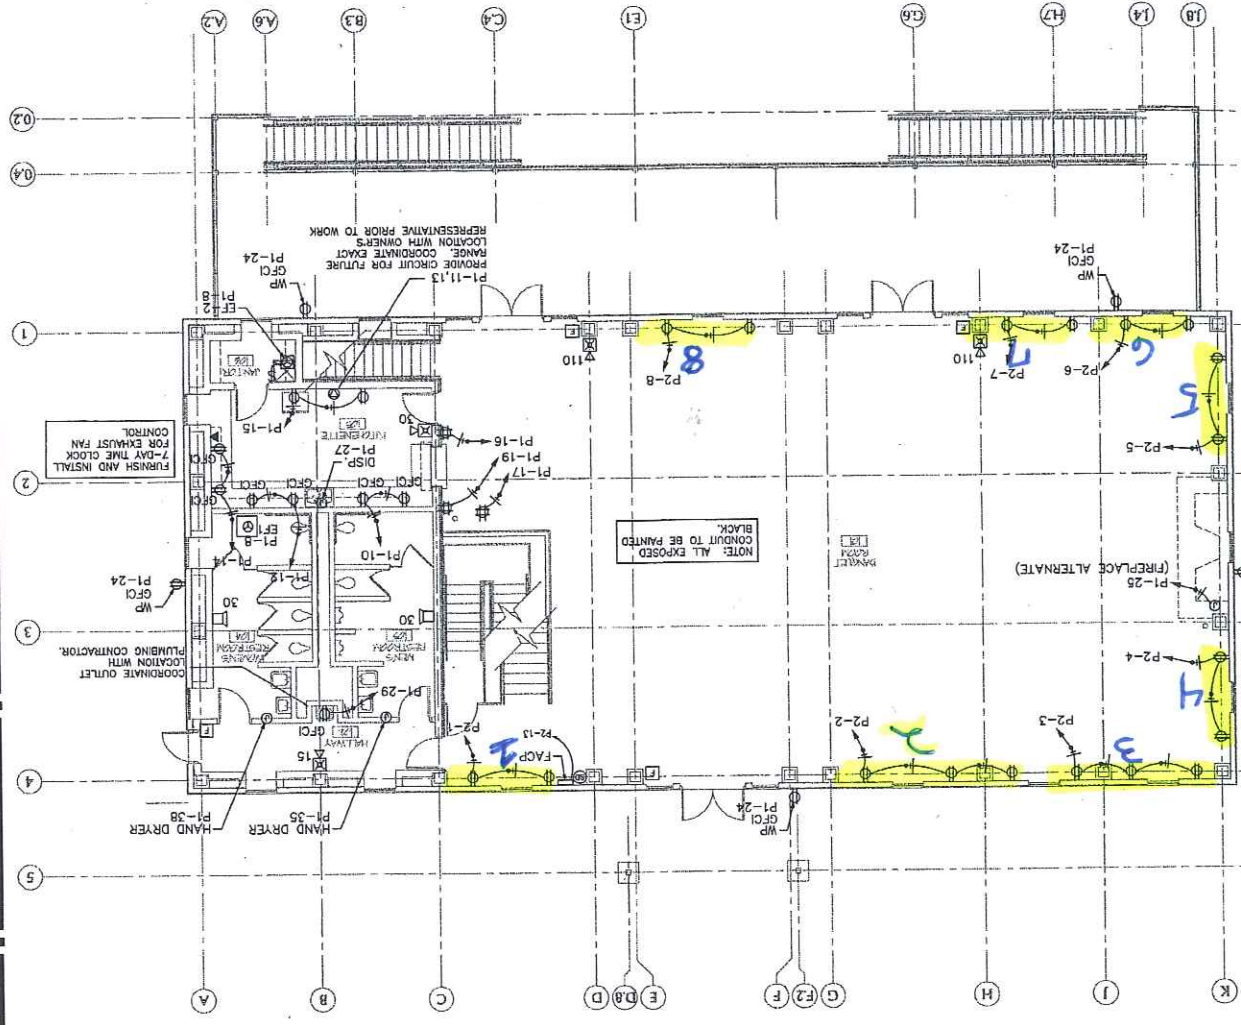

NOTE: ALL FIXTURES, ACCESSORIES, BOXES, CONDUITS, ETC. SHALL BE BLACK.

CALLOUT	SYMBOL	DESCRIPTION	MODEL	INPUT VOLTS	WATTS
A	⊗	CEILING FAN	HUNTER OUTDOOR ORIGINAL 25601 WITH 25673 BLADE	120V 1P 2W	300
B	— —	4 SURFACE STRIP	COLUMBIA LIGHTING CS4-232-EB8 120	120V 1P 2W	90
C	— —	4 SURFACE STRIP	COLUMBIA LIGHTING VL4-232-EB120WL-VLTS	120V 1P 2W	90
D	○	PENDANT	MCFADDEN TREND A20 BLACK LARGE IAR GLASS FROSTED WITH CAST DOME GUARD	120V 1P 2W	150
E	⊙	DUAL HEAD UPLIGHT	MCFADDEN C429-2 BLACK	120V 1P 2W	150
EM	⊕	EMERGENCY WALL PACK	DUALITE L22	120V 1P 2W	10
F	○	WALL SCOSCE	MCFADDEN 4809B BLACK	120V 1P 2W	150
G	○	CANOPY FIXTURE	MCFADDEN A19 BLACK	120V 1P 2W	150
H	⊕	WALL MTD. EXTERIOR	MCFADDEN A19 BLACK ARM WALL BRACKET B1	120V 1P 2W	150
J	⊕	POST MTD. EXTERIOR	MCFADDEN A19 BLACK ARM POST BRACKET B8	120V 1P 2W	150
X	⊕	EXIT	DUALITE LTRW	120V 1P 2W	10
X1	△	REMOTE HEAD	DUALITE OMS50605	120V 1P 2W	5


Sheet Title: **FIRST FLOOR ELECTRICAL PLANS**  
 Project No.: 3338  
 Scale: AS NOTED  
 Sheet No.: E2.0  
 Drawn By: PRS  
 Project Mgr.: LCG

**MUHLHAUSER BARN**  
 AT  
**BECKETT PARK**  
 8558 BECKETT ROAD  
 WEST CHESTER, OHIO 45069

Issue/Revision	Revision Number	Date
BD/PERMIT ISSUE	09/13/06	

Lee Grosser Associates Inc.  
 Consulting Engineers  
 2000 Alexandria Pike  
 Highland Hts. Ky 41076  
 659-441-0172 fax  
 659-441-0172 fax

McGill Smith Punshon, Inc.  
 3700 Park 42 Drive Suite 190B  
 Cincinnati, Ohio 45241-2097  
 Tel: 513-759-0004 • Fax: 513-563-7099  
 Planners • Architects • Surveyors  
 Engineers • Landscapers Architects

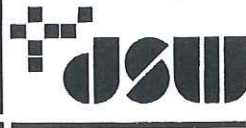

# LUMINAIRE SCHEDULE

CALLOUT	SYMBOL	DESCRIPTION	MODEL	INPUT WATTS	VOLTS
A		CEILING FAN	HUNTER OUTDOOR ORIGINAL 25601 WITH 25673 BLADE PROVIDE DOWNRODS AS REQUIRED	300	120V 1P 2W
B		4' SURFACE STRIP	COLUMBIA LIGHTING CS4-232-EBB 120	90	120V 1P 2W
C		4' SURFACE STRIP	COLUMBIA LIGHTING VL4-232-EBB120WL-VL7S	90	120V 1P 2W
D		PENDANT	MCFADDEN TREND A20 BLACK LARGE JAR GLASS FROSTED WITH CAST DOVE GUARD	150	120V 1P 2W
E		DUAL HEAD UPLIGHT	MCFADDEN C429-2 BLACK	150	120V 1P 2W
EM		EMERGENCY WALL PACK	DUALITE L22	10	120V 1P 2W
F		WALL SCONCE	MCFADDEN 4809B BLACK	150	120V 1P 2W
G		CANOPY FIXTURE	MCFADDEN A19 BLACK	150	120V 1P 2W
H		WALL MTD. EXTERIOR	MCFADDEN A19 BLACK ARM WALL BRACKET B1	150	120V 1P 2W
J		POST MTD. EXTERIOR	MCFADDEN A19 BLACK ARM POST BRACKET B3	150	120V 1P 2W
X		EXIT	DUALITE LTURW	10	120V 1P 2W
XI		REMOTE HEAD	DUALITE OMSSW060S	5	120V 1P 2W

NOTE: ALL FIXTURES, ACCESSORIES, BOXES, CONDUITS, ETC. SHALL BE BLACK.




McGill Smith-Punshon, Inc.  
3700 Park 42 Drive Suite 190B  
Cincinnati, Ohio 45241-2097  
Tel. 513-759-0004 • Fax. 513-563-7099  
Engineers • Architects • Surveyors  
Planners • Landscape Architects



Lee Grosser Associates Inc.  
Consulting Engineers  
3500 Alexander Pike  
Highland Hts. Ky 41076  
513-441-0144 phone  
513-441-0172 fax

Issue/Revision	Revision Number	Date
BD/PERMIT ISSUE		09/13/06

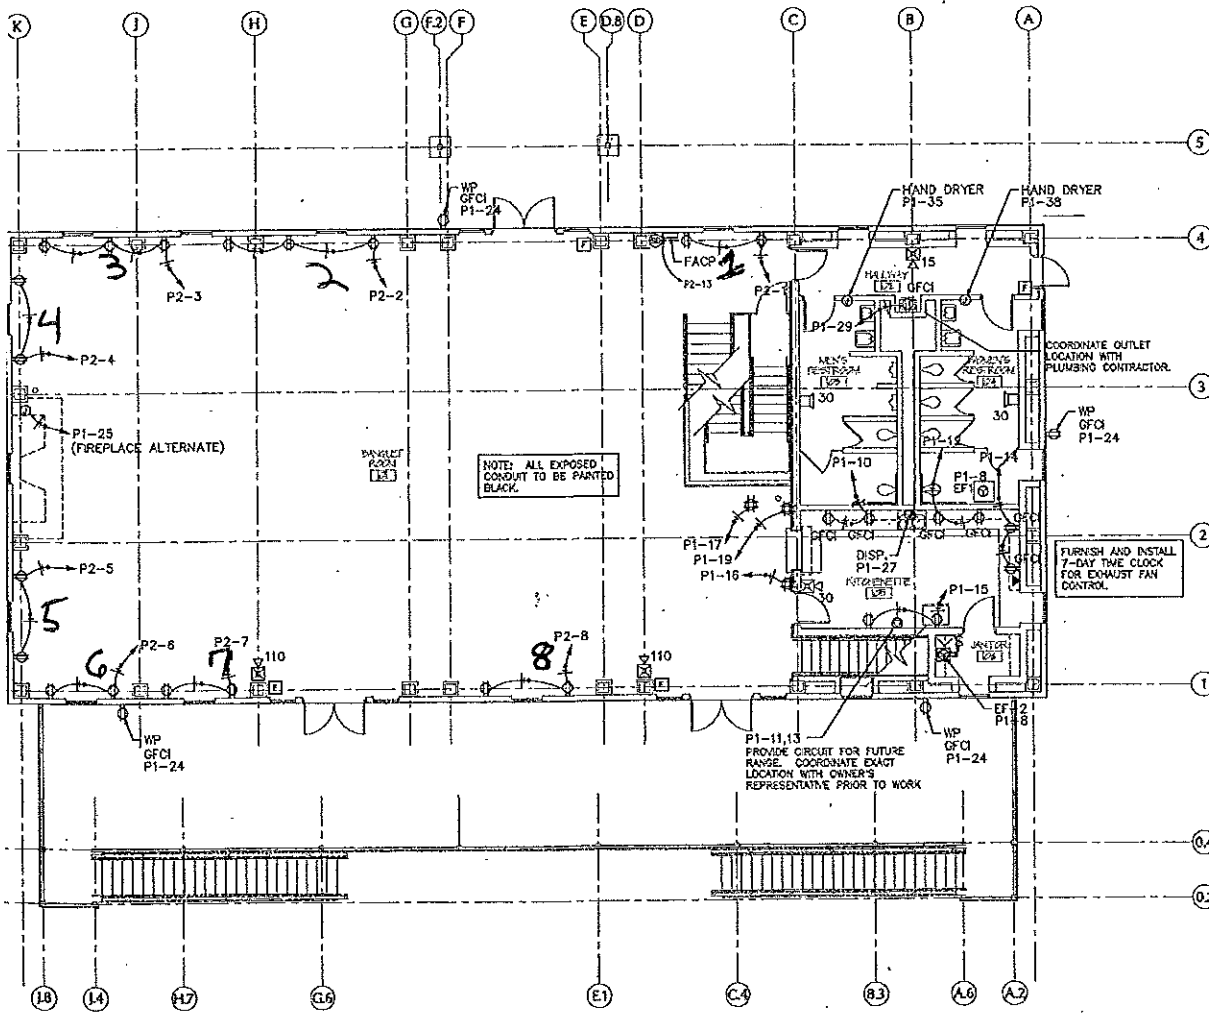

FIRST FLOOR ELECTRICAL POWER PLAN

SCALE: 1/8" = 1'-0"



**MUHLHAUSER BARN**  
AT  
**BECKETT PARK**  
8558 BECKETT ROAD  
WEST CHESTER, OHIO 45069

Sheet Title	FIRST FLOOR ELECTRICAL PLANS
Project No.	3338
Scale	AS NOTED
Sheet No.	E2.0
Drawn By	PRS
Project Mgr.	LCG